

200+ LUX AVERAGE - 0.7 UNIFORMITY

Calculation Summary									
Description	Avg	Max	Min	Min/Avg	Min/Max	Units	PtSpcLr	PtSpcTb	# Pts
Pitch	233.14	300	165	0.71	0.55	Lux	3.5	3.5	98

UWLR = 0.000

Luminaire Schedule						
Symbol	Qty	Label	Lum. Lumens	MF	Description	Filename
	8	SL6-4A	57384	0.900	Sportslite 6, 400w LED 5000K Optic A Asymmetric Wide Beam	5SBS00401-A.ies


NOTE:

Actual results achieved may vary from predicted values due to normal deviation in luminaire installation, electrical supply, equipment tolerances, obstructions including poles, brackets and mounting arms, reflectances etc.

This design is for general guidance only & its use is subject to conditions (available on request).

Based On

Lumen Output at 20000 Hours,
Lumen Output per Lamp Manufacturers Data,
Spot Lamp Replacement,
Normal Environment,
Annual Cleaning,
Ground is Level.

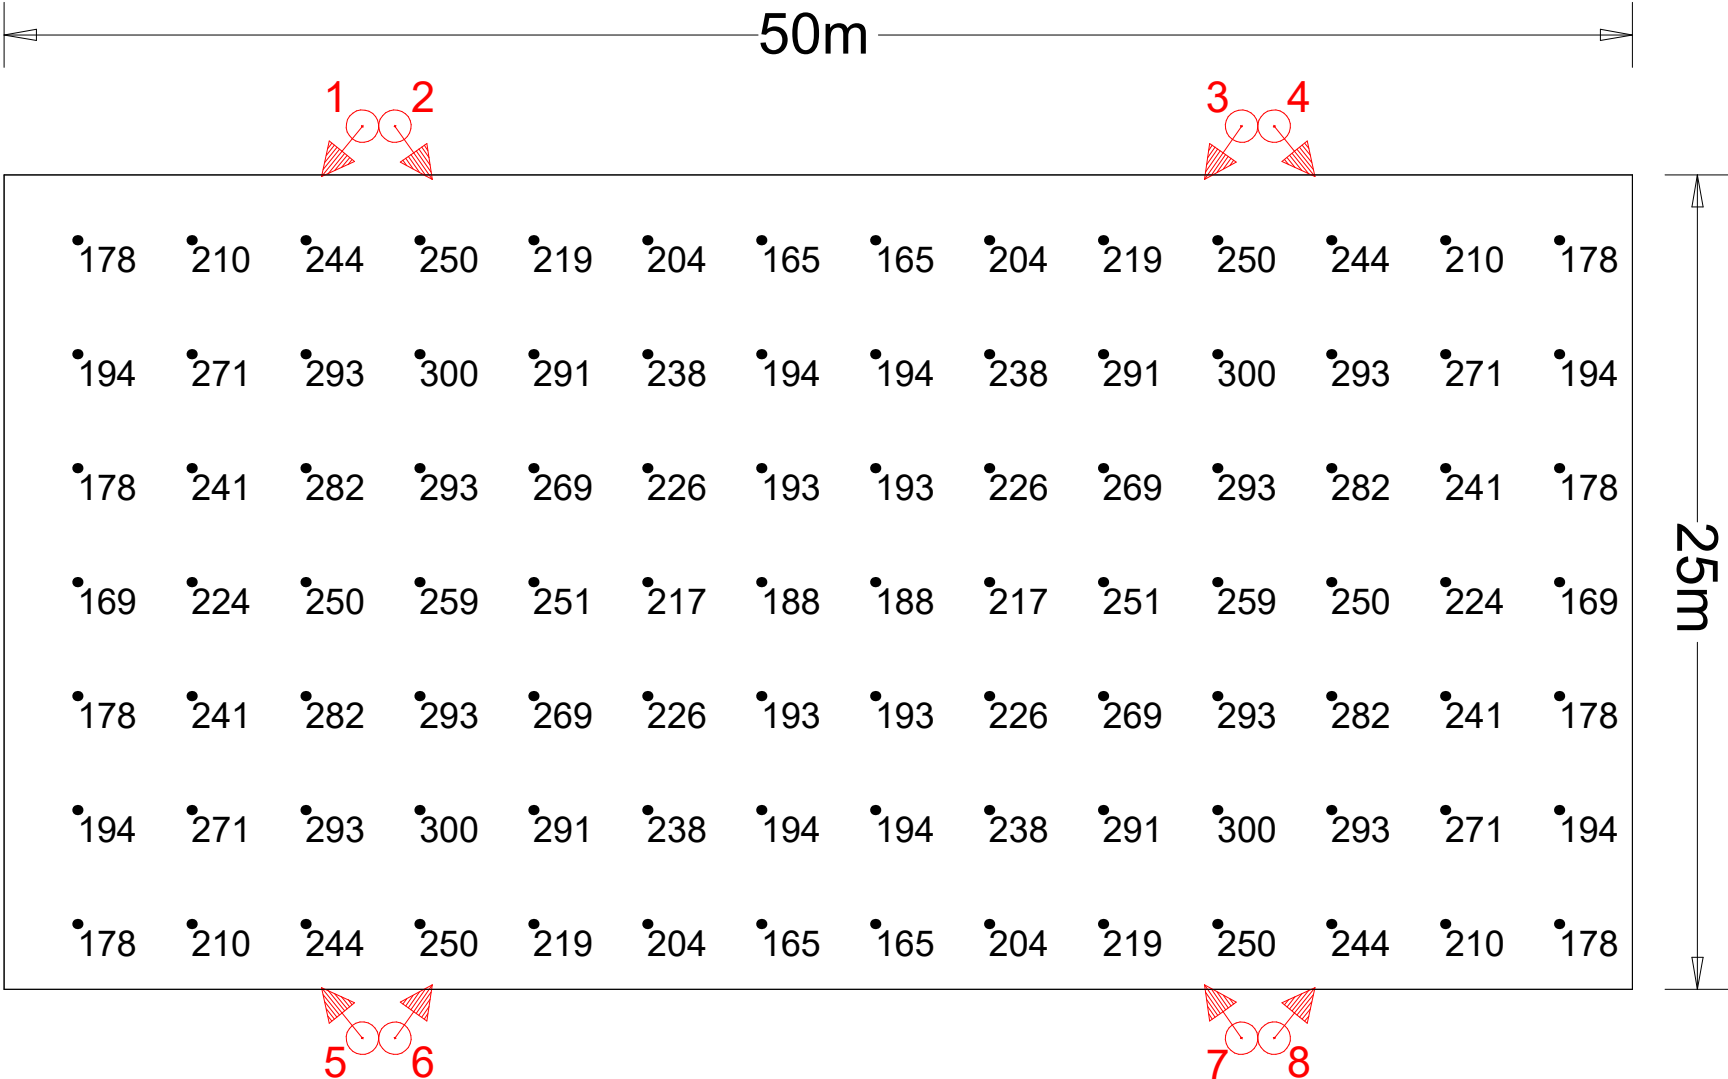

Luminaire Location Summary						
LumNo	Label	X	Y	Z	Orient	Tilt
1	SL6-4A	11	26.5	10	231	5
2	SL6-4A	12	26.5	10	305	5
3	SL6-4A	38	26.5	10	235	5
4	SL6-4A	39	26.5	10	309	5
5	SL6-4A	11	-1.5	10	129	5
6	SL6-4A	12	-1.5	10	55	5
7	SL6-4A	38	-1.5	10	125	5
8	SL6-4A	39	-1.5	10	51	5
Total Quantity: 8						

VeeLite		
Project: STANDARD PITCH - 50m x 25m 4 X 10m POLES CIBSE LG4 - Class II		
Client: Veelite		
Project No: XX-XX-XX	Drawing No: XX-XX-XX-XX	Drawn By: DS
Date: 14/12/2023	Scale: As shown	REV NO: -
50m x 25m, 200 lux - 4 x 10mP, 8xSL6-4A.AGI		