

250 LUX AVERAGE - 0.6 UNIFORMITY

Calculation Summary									
Description	Avg	Max	Min	Min/Avg	Min/Max	Units	PtSpcLr	PtSpcTb	# Pts
Pitch	250.31	363	149	0.60	0.41	Lux	3.5	3.5	98

UWLR = 0.002

Luminaire Schedule						
Symbol	Qty	Label	Lum. Lumens	MF	Description	Filename
	8	SL6-4A	57384	0.900	Sportslite 6, 400w LED 5000K Optic A Asymmetric Wide Beam	5SBS00401-A.ies


NOTE:

Actual results achieved may vary from predicted values due to normal deviation in luminaire installation, electrical supply, equipment tolerances, obstructions including poles, brackets and mounting arms, reflectances etc.

This design is for general guidance only & its use is subject to conditions (available on request).

Based On

Lumen Output at 20000 Hours,
Lumen Output per Lamp Manufacturers Data,
Spot Lamp Replacement,
Normal Environment,
Annual Cleaning,
Ground is Level.

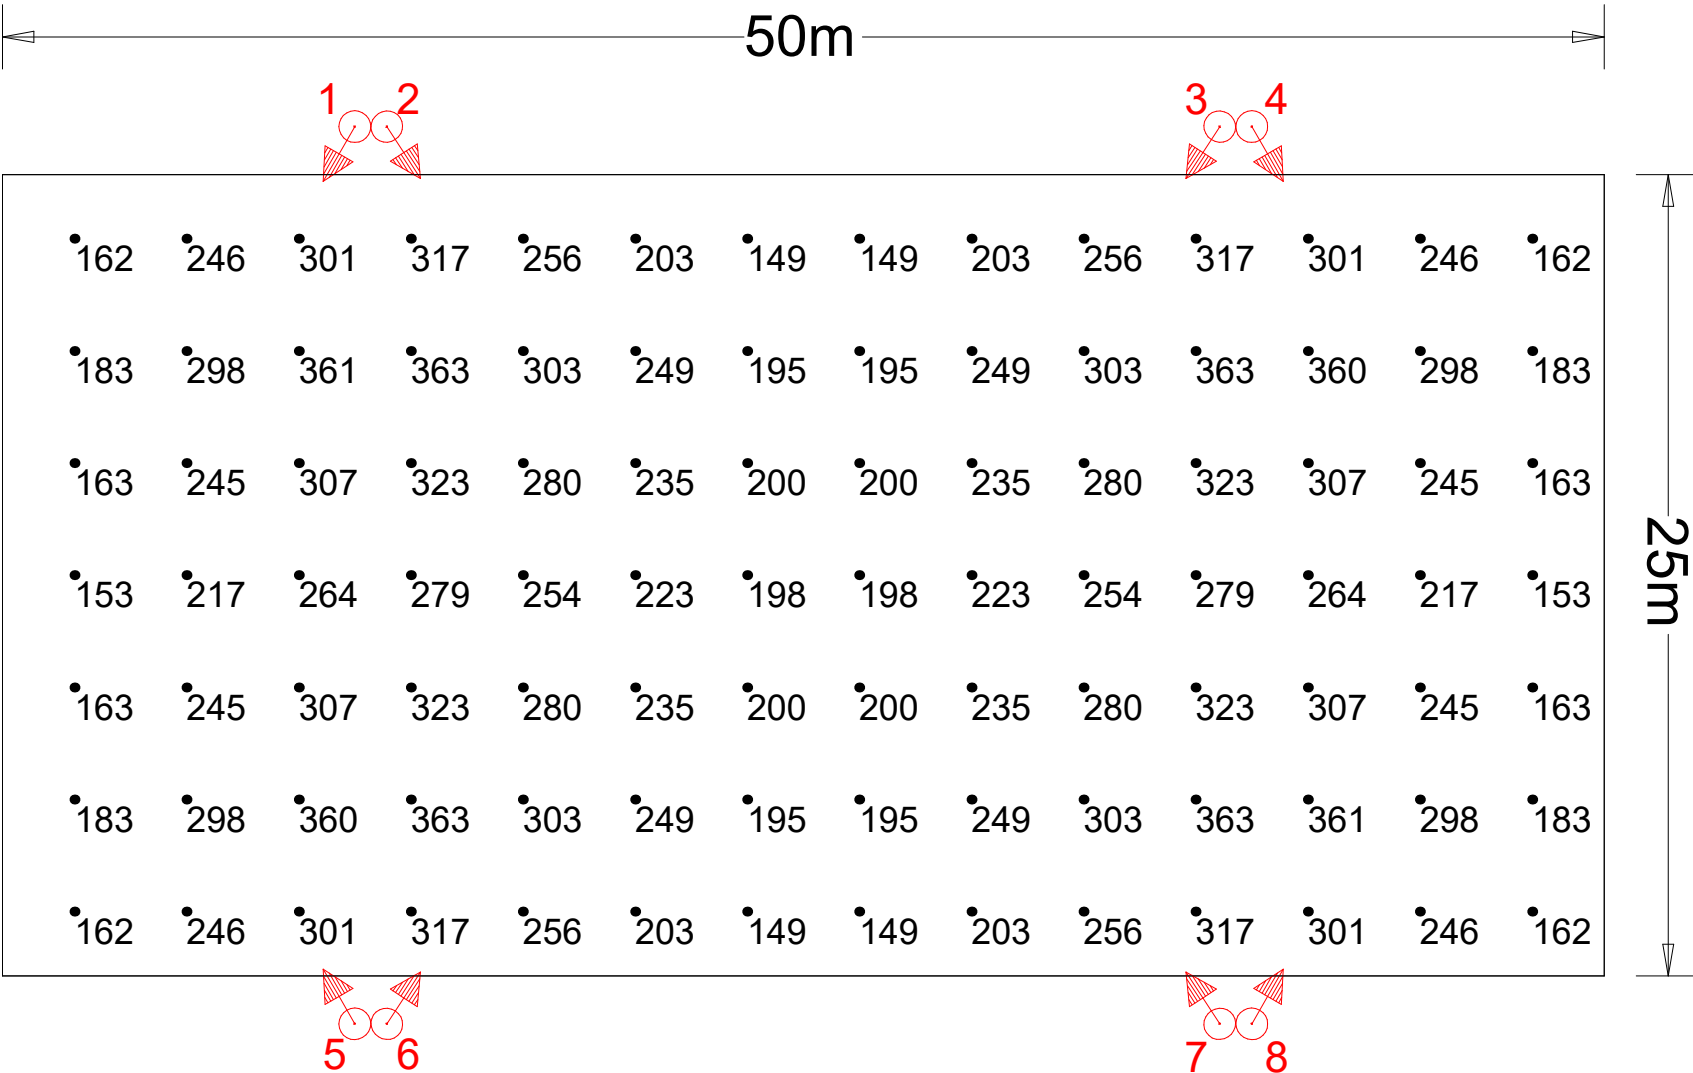

VeeLite		
Project: STANDARD PITCH - 50m x 25m 4 X 8m POLES CIBSE LG4 - Class II		
Client: Veelite		
Project No: XX-XX-XX	Drawing No: XX-XX-XX-XX	Drawn By: DS
Date: 18/12/2024	Scale: As shown	REV NO: ■
50m x 25m, 250 lux - 4 x 8mP, 8xSL6-4A.AGI		

Luminaire Location Summary						
LumNo	Label	X	Y	Z	Orient	Tilt
1	SL6-4A	11	26.5	8	240	10
2	SL6-4A	12	26.5	8	303	15
3	SL6-4A	38	26.5	8	237	15
4	SL6-4A	39	26.5	8	300	10
5	SL6-4A	11	-1.5	8	120	10
6	SL6-4A	12	-1.5	8	57	15
7	SL6-4A	38	-1.5	8	123	15
8	SL6-4A	39	-1.5	8	60	10
Total Quantity: 8						